


ELECTRICAL LEGEND :-

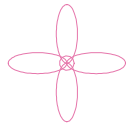

CEILING SWEEP FAN.
1200mm.

1X18W FLUORESCENT LIGHT FITTING
DIFFUSED.

1X36W FLUORESCENT LIGHT FITTING
DIFFUSED.

DOUBLE G.P.O.


SINGLE 15 Amp G.P.O.

SWITCH RUN


AIR CONDITIONER

WALL EXHAUST FAN

SMOKE DETECTOR

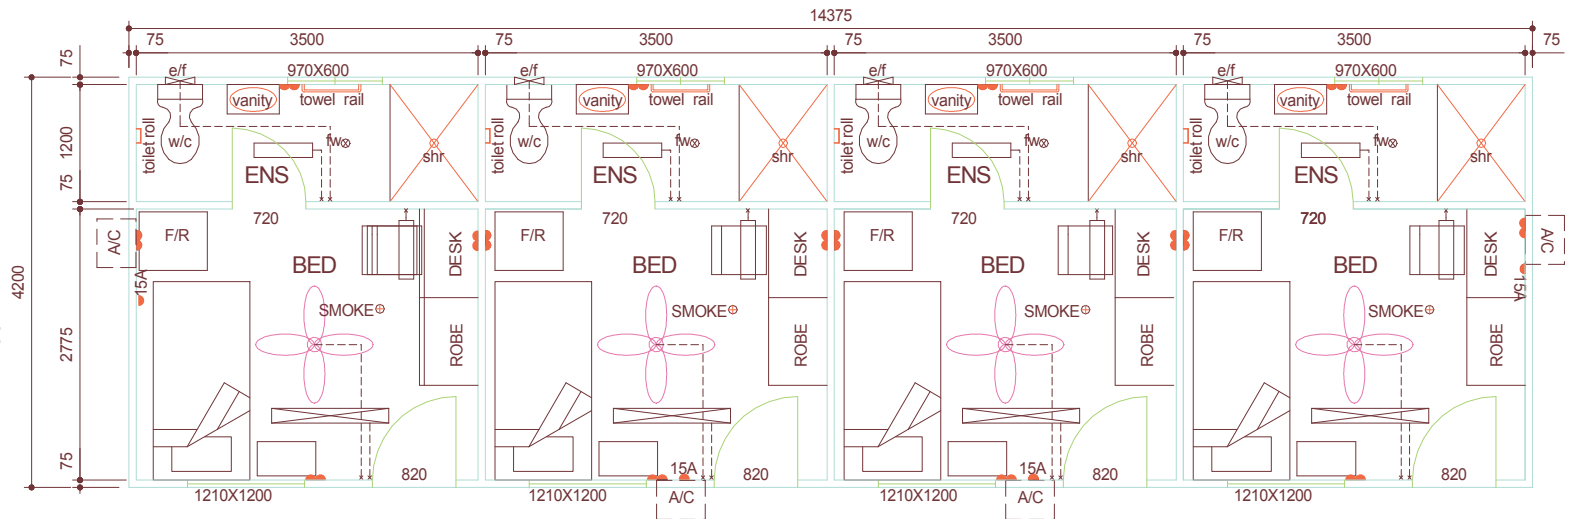

FLOOR PLAN

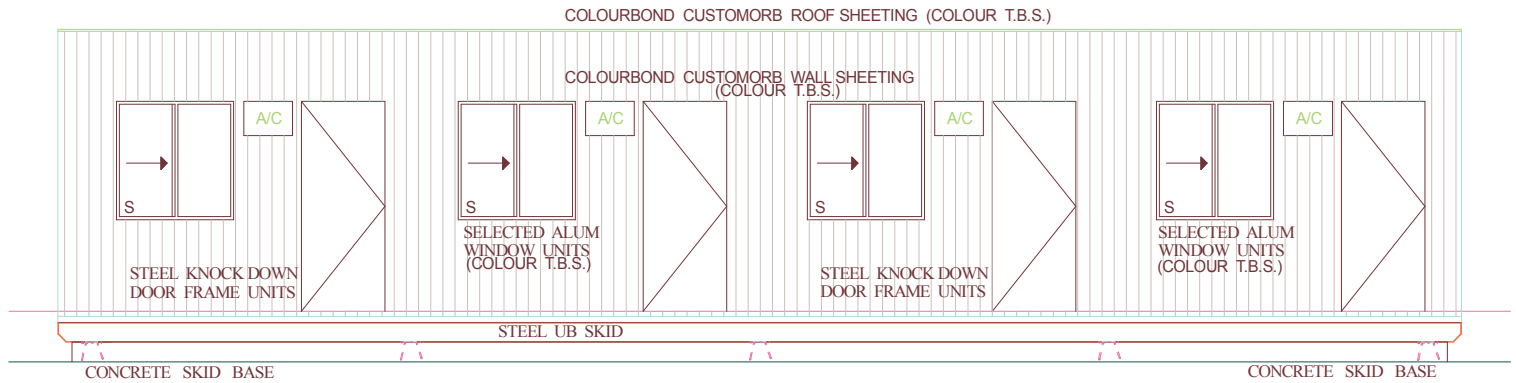

FRONT ELEVATION

NOTE :-

THIS DRAWING IS COPYRIGHT AND MUST NOT
BE USED OR COPIED WITHOUT PRIOR
AUTHORISATION FROM B & J BUILDING



B & J BUILDING CONSULTANTS & STEEL SUPPLIES
PHONE :- 91926262 - 91926263 FAX :- 91926264
Lot 50, Port Drive, Broome.
P.O. Box 1308, Broome. W.A. 6725

JOB TYPE

CHECKED

TRADESMAN
DATE

CLIENT:- SALES DEPT.

ADDRESS:- AS DIRECTED.

DESCRIPTION:- FLOOR PLAN - ELEVATION THE FITZROY.

SCALE 1 - 50
DRAWN PHIL
JOB NO XX
DWG NO XX
DATE X